


PRODUCED BY AN AUTODESK EDUCATIONAL PRODUCT

PRODUCED BY AN AUTODESK EDUCATIONAL PRODUCT

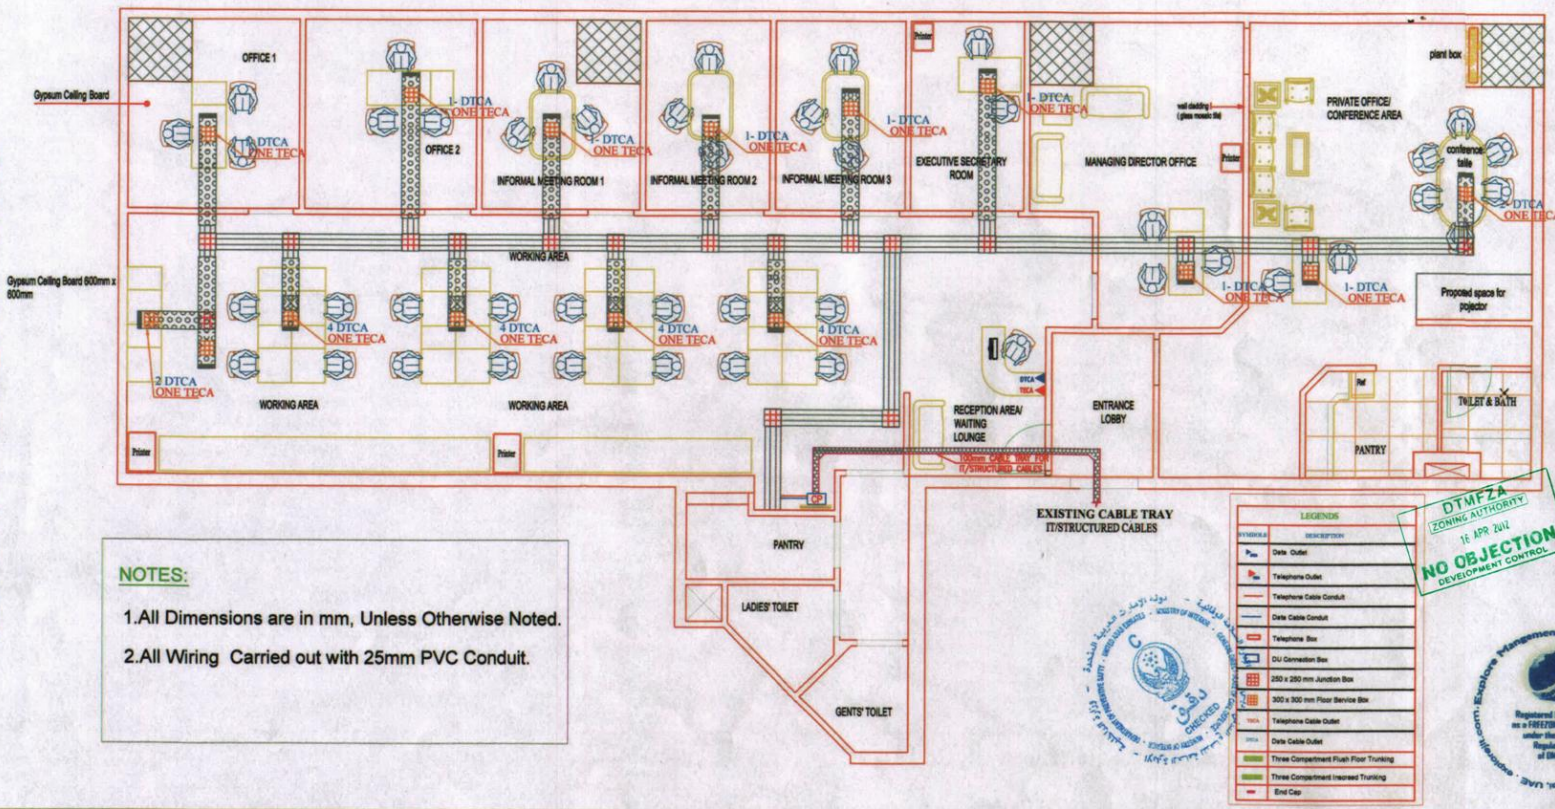

NOTES:

- All Dimensions are in mm, Unless Otherwise Noted.
- All Wiring Carried out with 25mm PVC Conduit.

LEGENDS

	Data Outlet
	Telephone Outlet
	Telephone Cable Conduit
	Data Cable Conduit
	Telephone Box
	2U Connection Box
	250 x 250 mm Junction Box
	300 x 300 mm Floor Service Box
	Telephone Cable Outlet
	Data Cable Outlet
	Three Compartment Flush Floor Trunking
	Three Compartment Inrased Trunking
	End Cap

DTMFA ZONING AUTHORITY
16 APR 2011
NO OBJECTION
DEVELOPMENT CONTROL



CLIENT

Mr. MANOJ KANTI PAUL
PO BOX :11682
ABUDHABI .UAE.

CONSULTANT

Explore
Management Consultancy J.L.T
ACTIVITIES: Consultancy Services in Engineering & Project Management

X2 Office Tower, 29th Floor, Units: 2909 & 2910,
Jumeirah Lake Towers, P.O. Box: 68968, Dubai-U.A.E.
Email: mkpaul@emirates.net.ae, Mob: +971504429331,
www.explorejlt.com

CONTRACTOR

AL HASOUN AL ARABIAH CONTRACTING & ELECTROMECHANICAL WORKS EST.

P.O Box : 65568, Dubai, UAE,
Tel. : (+971-4) 3978373, Fax : (+971-4) 3978363.
Mob: +971505244565
Email : alhasoun@emirates.net.ae
www.alhasoun.ae

PROJECT

PROPOSED OFFICE INTERIOR FITOUT WORKS AT OMNIYAT TOWER, 3rd FLOOR OFFICE UNITS UNITS 304, OMNIYAT TOWER, DUBAI, UAE.

DRAWING TITLE

PROPOSED - VOICE & DATA LAYOUT PLAN 03rd Floor (Office Unit -304)

DRAWING NUMBER :
SCALE : 1:50 SIZE : A3

00	DWG. FOR APPROVAL	2/01/2012	Blasoo	JL.DEB
REV.	DESCRIPTION	DATE	DRAWN	CHKD